


STORAGE AREA MECHANICAL PLAN

Scale: 1/4"=1'-0"

- NOTES:
- 1 DEMO EXISTING 12x10 DUCT IN THIS AREA. REPLACE WITH 16x14 AND BALANCE TO 1450 CFM.
 - 2 EXISTING O.A. DUCT BALANCED FOR 760 CFM. REBALANCE TO 0 CFM.
 - 3 EXISTING 7.5 TON WATER SOURCE HEAT PUMP--3000 CFM.
 - 4 EXISTING TOILET EXHAUST FAN--250 CFM.
 - 5 3800 CFM EXHAUST & 3125 CFM RELIEF THROUGH KITCHEN HOOD.
 - 6 525 CFM EXHAUST THROUGH KITCHEN HOOD.

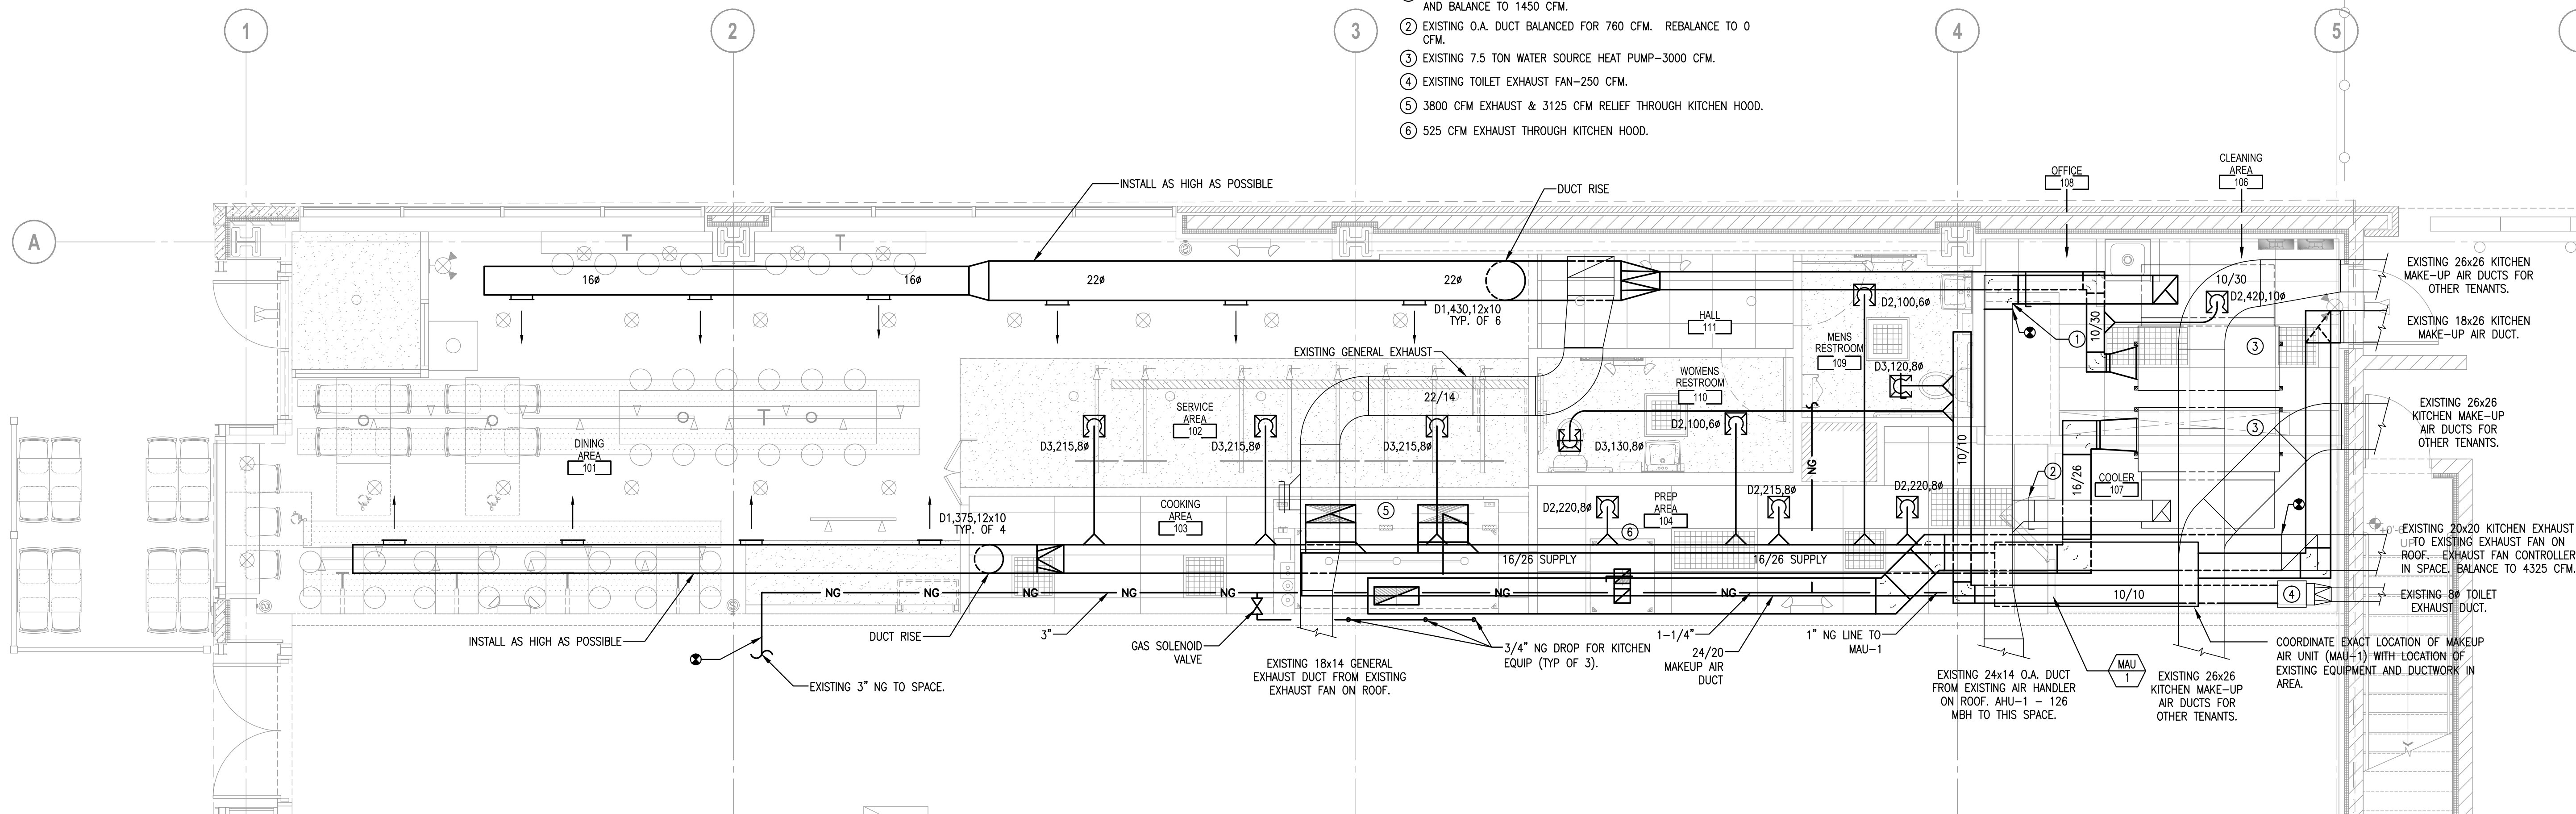

GROUND FLOOR MECHANICAL PLAN

Scale: 1/4"=1'-0"

LINGLEDESIGNGROUP, INC.
 WEST MAIN STREET
 LEVIA, IL 61048-1158
 PHONE: 815-369-9155
 FAX: 815-369-4495
 WWW.LINGLEDESIGN.COM



1488 Reed Street, Suite 100
 Naperville, Illinois 60563-6003
 LARSON ENGINEERING, INC.
 LICENSE NUMBER: 07-0000044
 ILL. COMM. NO. 2400004000
 COPYRIGHT © 2010
Larson Engineering Inc.

© ALL DRAWINGS AND WRITTEN MATERIAL CONTAINED HEREIN ARE THE PROPERTY OF THE ARCHITECT. THEY MAY NOT BE REPRODUCED, COPIED, REUSED, OR DISCLOSED IN ANY MANNER WITHOUT WRITTEN AUTHORIZATION FROM THE ARCHITECT.

Qdoba MEXICAN GRILL
 20 E. Chicago Avenue
 Chicago, IL 60611-2009

REVISIONS:	DATE:	DESCRIPTION:
#	07/08/10	ISSUED FOR PERMIT

PROJECT NUMBER: 09-116
 DRAWN BY: LEM
 CHECKED BY: JKN

SHEET TITLE:
MECHANICAL PLAN

SHEET NUMBER:
M2.0

X:\2009 MEP\2409046.000_Lingle Design Group, Inc.-Qdoba Mexican Grill-Chicago IL Drawings\2409046-M2.0.dwg, Copyright ©2009 Larson Engineering, Inc., Plotted: 1/9/2010 4:16 PM, m249