



WATER RISER

Scale: NO SCALE

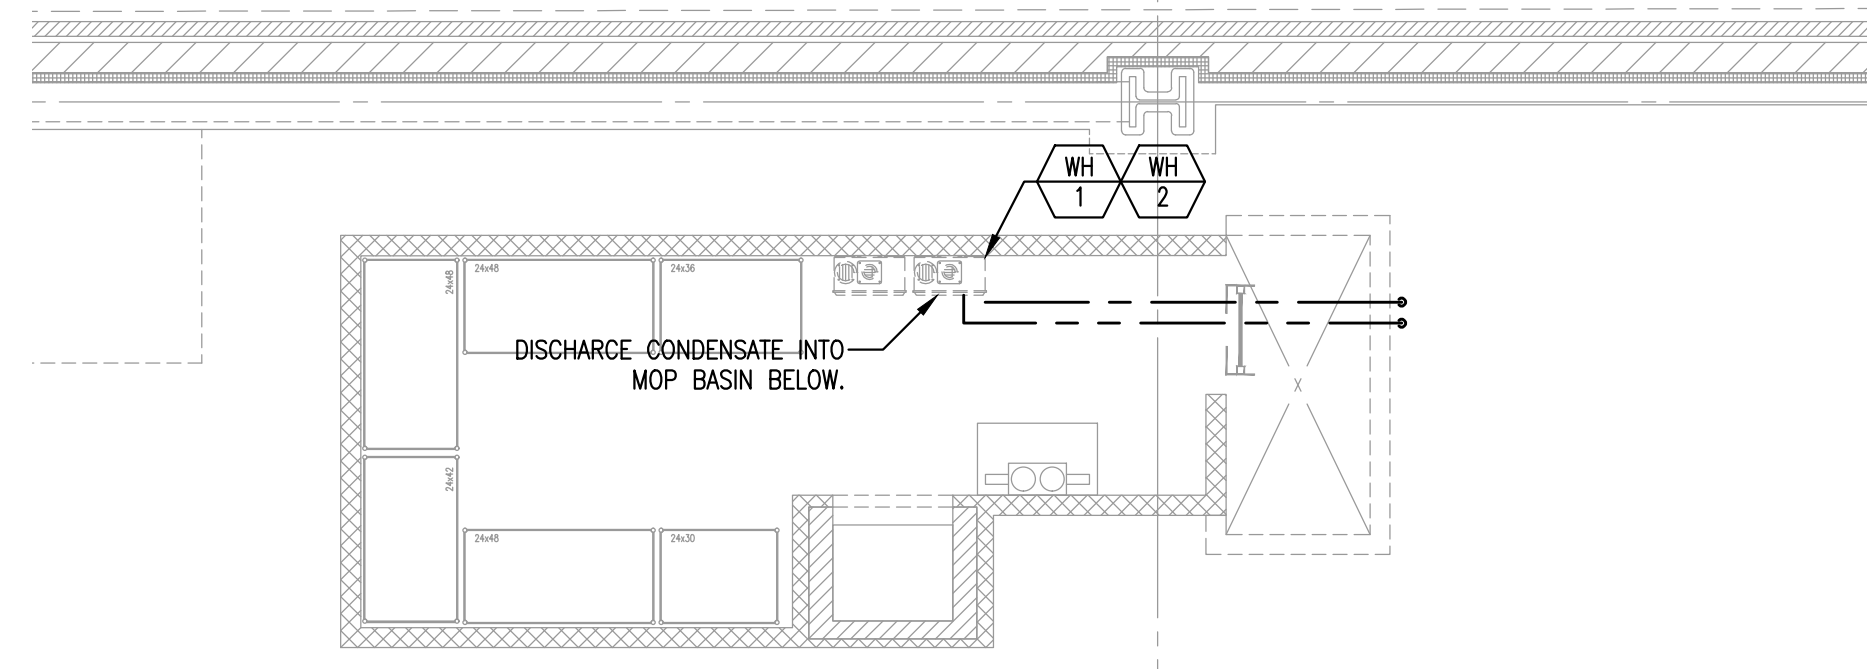

MEZZANINE PLUMBING PLAN

Scale: 1/4"=1'-0"

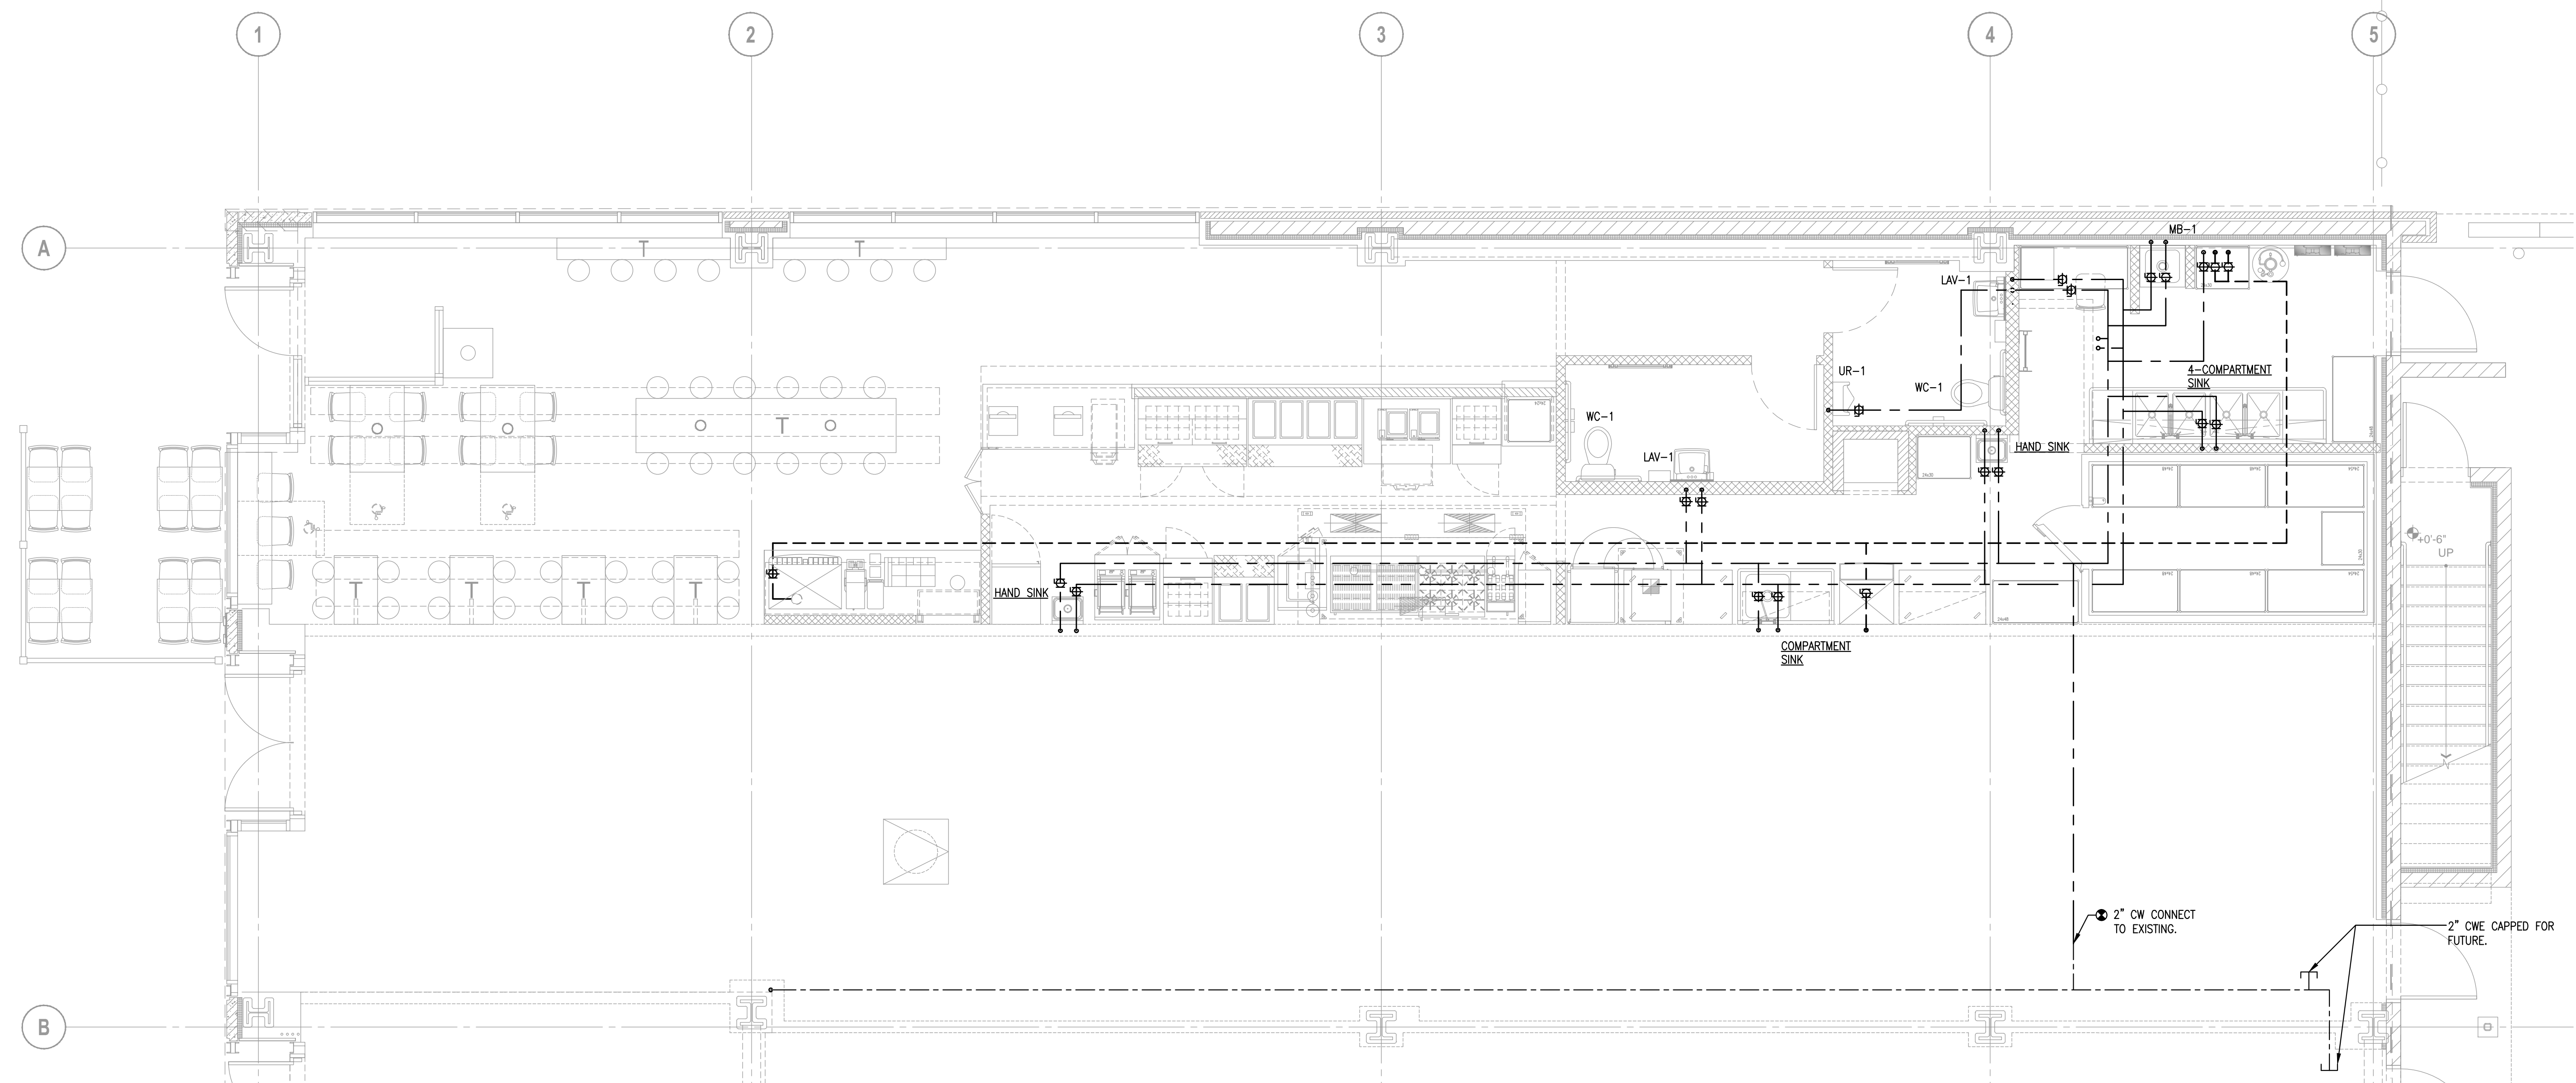

GROUND FLOOR PLUMBING PLAN

Scale: 1/4"=1'-0"

LINGLEDESIGNGROUP, INC.
 WEST MAIN STREET
 LEVA, IL 61048-1136
 PHONE: 815-369-9155
 FAX: 815-369-4495
 WWW.LINGLEDESIGN.COM



1488 Reed Street, Suite 100
 Naperville, Illinois 60563-6003
 LARSON ENGINEERING, INC.
 LICENSED PROFESSIONAL ENGINEER
 ILL. COMM. NO. 24090046.000
 COPYRIGHT © 2010

© ALL DRAWINGS AND WRITTEN MATERIAL CONTAINED HEREIN ARE THE PROPERTY OF THE ARCHITECT. THEY MAY NOT BE REPRODUCED, COPIED, REUSED, OR DISCLOSED IN ANY MANNER WITHOUT WRITTEN AUTHORIZATION FROM THE ARCHITECT.

Qdoba
 MEXICAN GRILL
 20 E. Chicago Avenue
 Chicago, IL 60611-2009

REVISIONS #	DATE	DESCRIPTION
1	07/08/10	ISSUED FOR PERMIT

PROJECT NUMBER: 09-116
 DRAWN BY: LEM
 CHECKED BY: JKN

SHEET TITLE:
WATER PLUMBING PLAN

SHEET NUMBER:
P2.1

X:\2009 MEP\24090046.000_Lingle Design Group, Inc.-Qdoba Mexican Grill-Chicago IL\Drawings\24090046-P2.0.dwg, Copyright ©2009 Larson Engineering, Inc., Plotted: 1/9/2010 4:17 PM, m249