



X:\2009 MEP\2409046.000\_Lingle Design Group, Inc., Dobba Mexican Grill-Chicago IL Drawings\2409046-M2.0.dwg, Copyright ©2009 Larson Engineering, Inc., Plotted: 1/19/2010 8:47 AM, 1:197

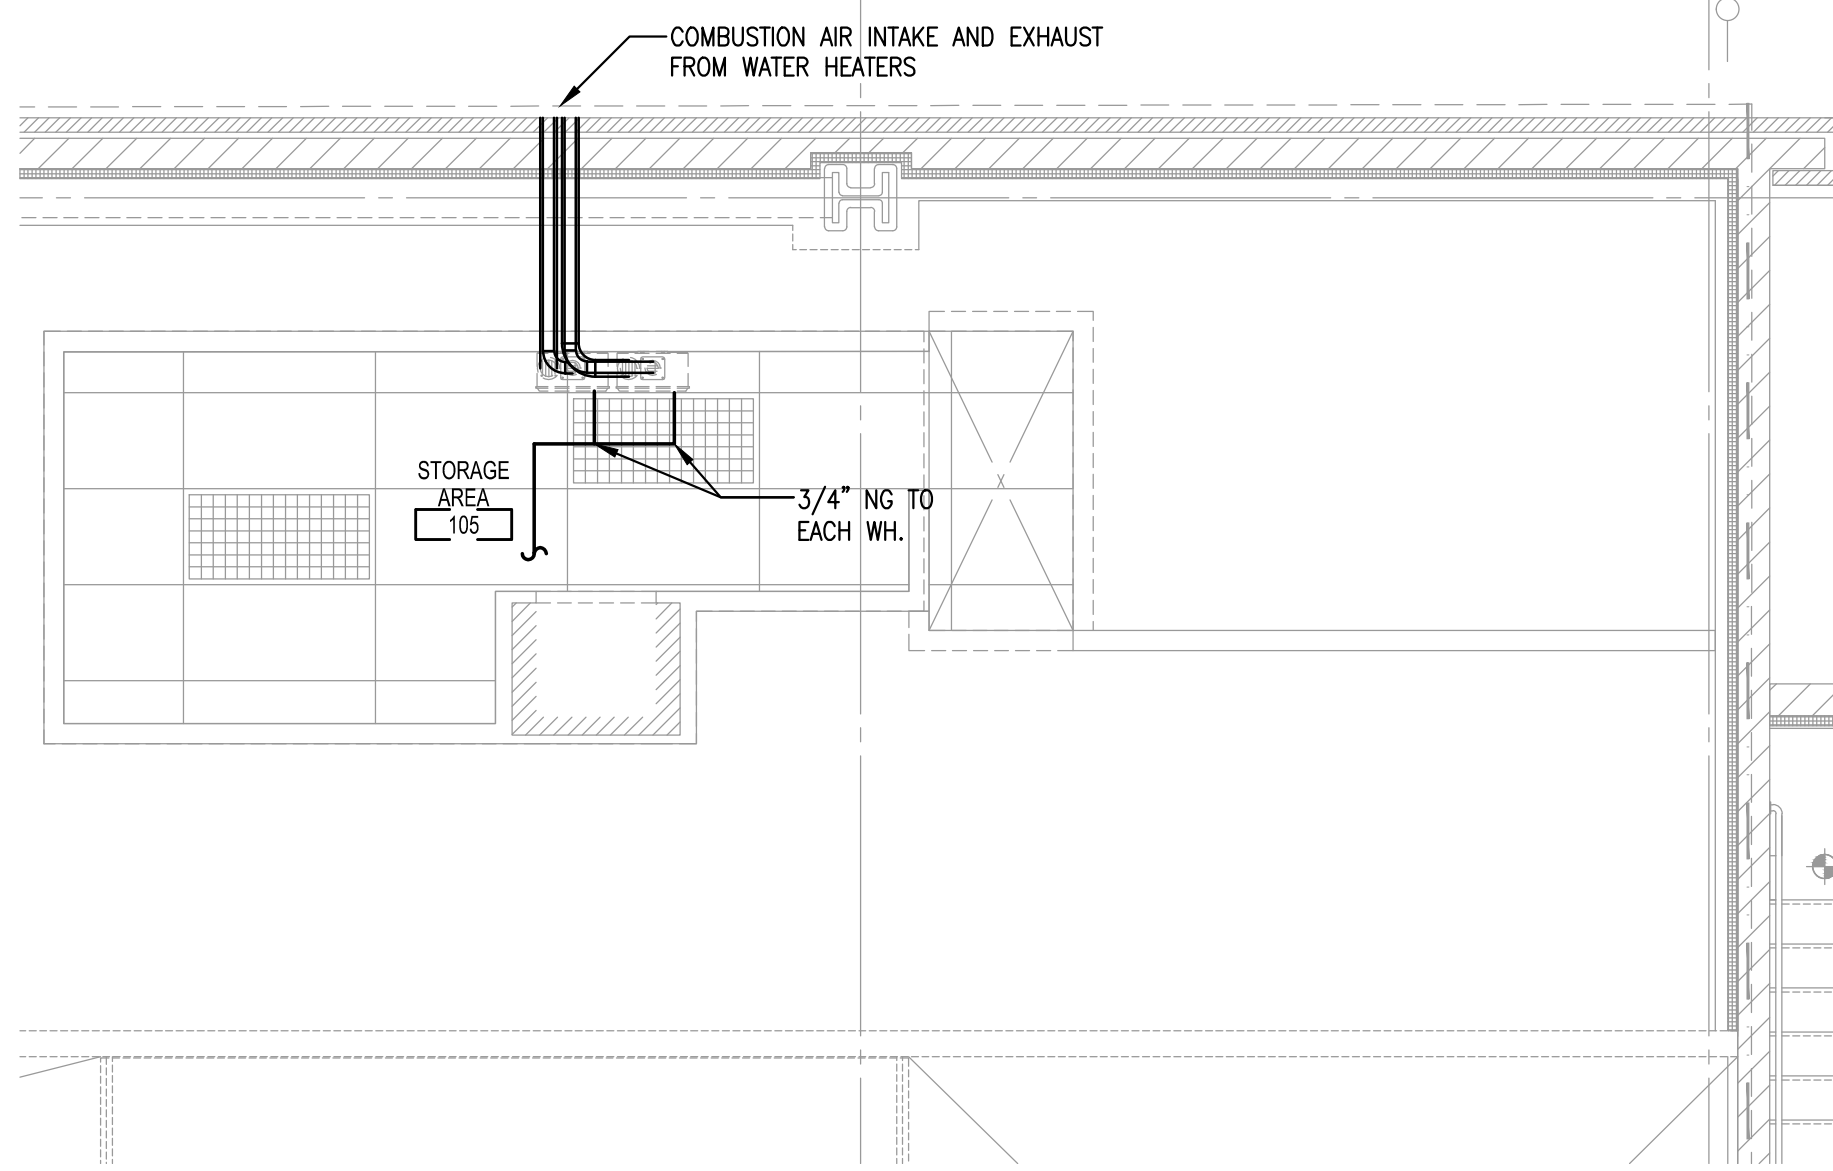

**STORAGE AREA MECHANICAL PLAN**

Scale: 1/4"=1'-0"

- NOTES:
- 1 DEMO EXISTING 12x10 DUCT IN THIS AREA. REPLACE WITH 16x14 AND BALANCE TO 1450 CFM.
  - 2 EXISTING O.A. DUCT BALANCED FOR 760 CFM. REBALANCE TO 0 CFM.
  - 3 EXISTING 7.5 TON WATER SOURCE HEAT PUMP-3000 CFM.
  - 4 EXISTING TOILET EXHAUST FAN-250 CFM.
  - 5 3800 CFM EXHAUST & 3125 CFM RELIEF THROUGH KITCHEN HOOD.
  - 6 525 CFM EXHAUST THROUGH KITCHEN HOOD.

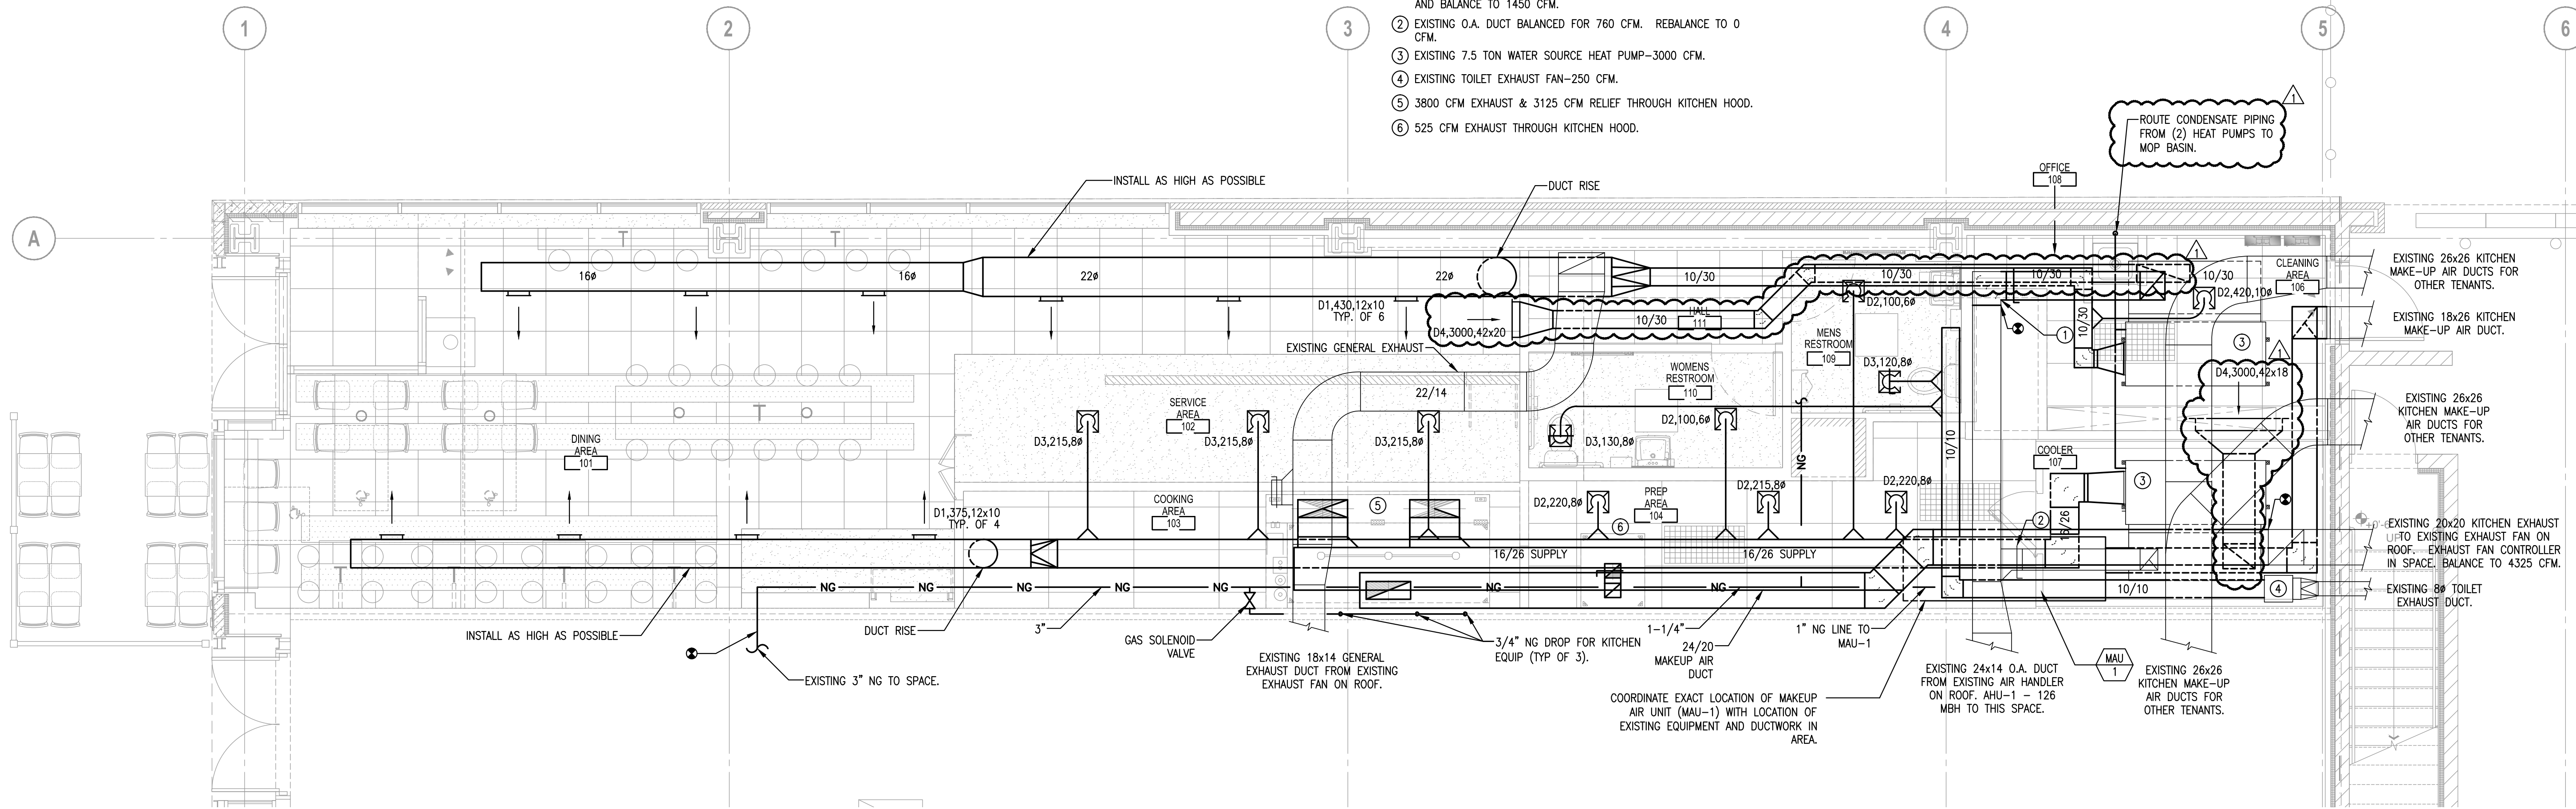

**GROUND FLOOR MECHANICAL PLAN**

Scale: 1/4"=1'-0"

LINGLEDESIGNGROUP, INC.  
 WEST MAIN STREET  
 LEVIA, IL 61048-1158  
 PHONE: 815-369-9155  
 FAX: 815-369-4495  
 WWW.LINGLEDESIGN.COM



1488 Reed Street, Suite 100  
 Naperville, Illinois 60563-6003  
 LARSON ENGINEERING, INC.  
 U.S. COMM. NO. 2409046.000  
 COPYRIGHT © 2010  
**Larson Engineering Inc.**

© ALL DRAWINGS AND WRITTEN MATERIAL CONTAINED HEREIN ARE THE PROPERTY OF THE ARCHITECT. THEY MAY NOT BE REPRODUCED, COPIED, REUSED, OR DISCLOSED IN ANY MANNER WITHOUT WRITTEN AUTHORIZATION FROM THE ARCHITECT.

**Dobba MEXICAN GRILL**  
 20 E. Chicago Avenue  
 Chicago, IL 60611-2009

REVISIONS:	DATE:	DESCRIPTION:
1	1/8/10	ISSUED FOR PERMIT
2	1/18/10	ISSUED FOR PERMIT

PROJECT NUMBER: 09-116  
 DRAWN BY: LEM  
 CHECKED BY: JKN

SHEET TITLE:  
**MECHANICAL PLAN**

SHEET NUMBER:  
**M2.0**