


SANITARY WASTE RISER

KITCHEN WASTE RISER

Scale: NO SCALE

Scale: NO SCALE

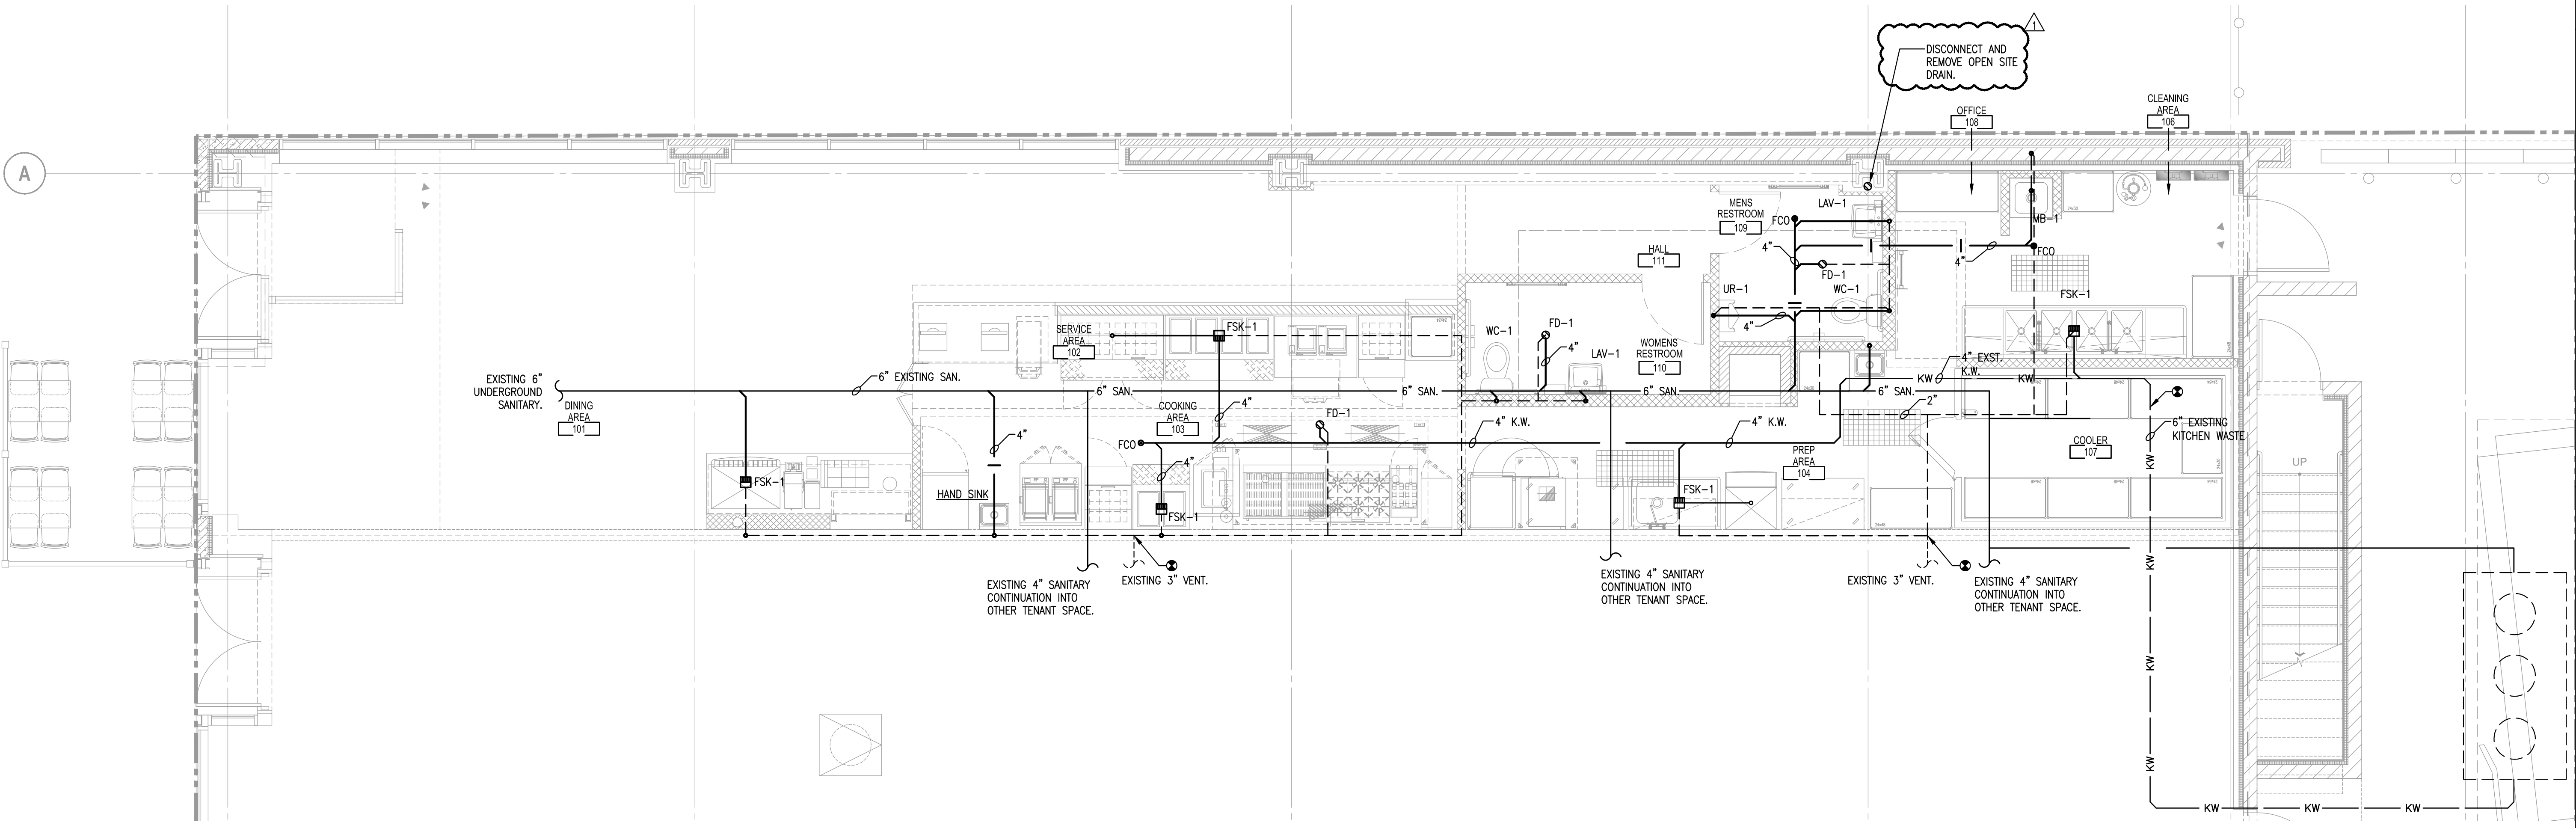

GROUND FLOOR PLUMBING PLAN

Scale: 1/4"=1'-0"

LINGLEDESIGNGROUP, INC.
WEST MAIN STREET
LEVA, IL 61048-1156
PHONE: 815-369-9155
FAX: 815-369-4495
WWW.LINGLEDESIGN.COM



1408 Reed Street, Suite 100
Naperville, Illinois 60563-6003
LAW OFFICE OF JAMES J. LINGLE
ILL. COURT. NO. 24900046.000
COPYRIGHT © 2010
Larson Engineering Inc.

© ALL DRAWINGS AND WRITTEN MATERIAL CONTAINED HEREIN ARE THE PROPERTY OF THE ARCHITECT. THEY MAY NOT BE REPRODUCED, COPIED, REUSED, OR DISCLOSED IN ANY MANNER WITHOUT WRITTEN AUTHORIZATION FROM THE ARCHITECT.



REVISIONS:	DATE:	DESCRIPTION:
#	1/8/10	ISSUED FOR BID
Δ	1/18/10	ISSUED FOR PERMIT

PROJECT NUMBER: 09-116
DRAWN BY: LEM
CHECKED BY: JKN

SHEET TITLE:
SANITARY PLUMBING PLAN

SHEET NUMBER:
P2.0

X:\2009 MEP\24900046.000_Lingle Design Group, Inc.-Qdoba Mexican Grill-Chicago IL Drawings\24900046-P2.0.dwg, Copyright ©2009 Larson Engineering, Inc., Plotted: 1/19/2010 8:47 AM, 1r197