

REVISIONS
JANUARY 6, 2015 ISSUED FOR BID/CONSTRUCTION

PROPOSED DEVELOPMENT FOR:
BOLINGBROOK SEMU, LLC.
LOCATION
123 N. WEBER ROAD
BOLINGBROOK, ILLINOIS

Reitan Architects, LLC.
1325 Willey Road - Suite 166 - Schaumburg, Illinois 60173
PH. 847-519-1227 - FAX 847-519-0347
Assumed Name No. 184-004083


THIS IS TO CERTIFY THAT THESE PLANS WERE PREPARED UNDER MY PERSONAL SUPERVISION AND TO THE BEST OF MY KNOWLEDGE AND BELIEF THEY COMPLY WITH ALL CITY ORDINANCES OF THE VILLAGE OF BOLINGBROOK, ILLINOIS.

SHEET NAME
SITE
ELECTRICAL
PLAN

SHEET
E2
OF 2

© Copyright, Reitan Architects, LLC.

PROJECT NO.
1414

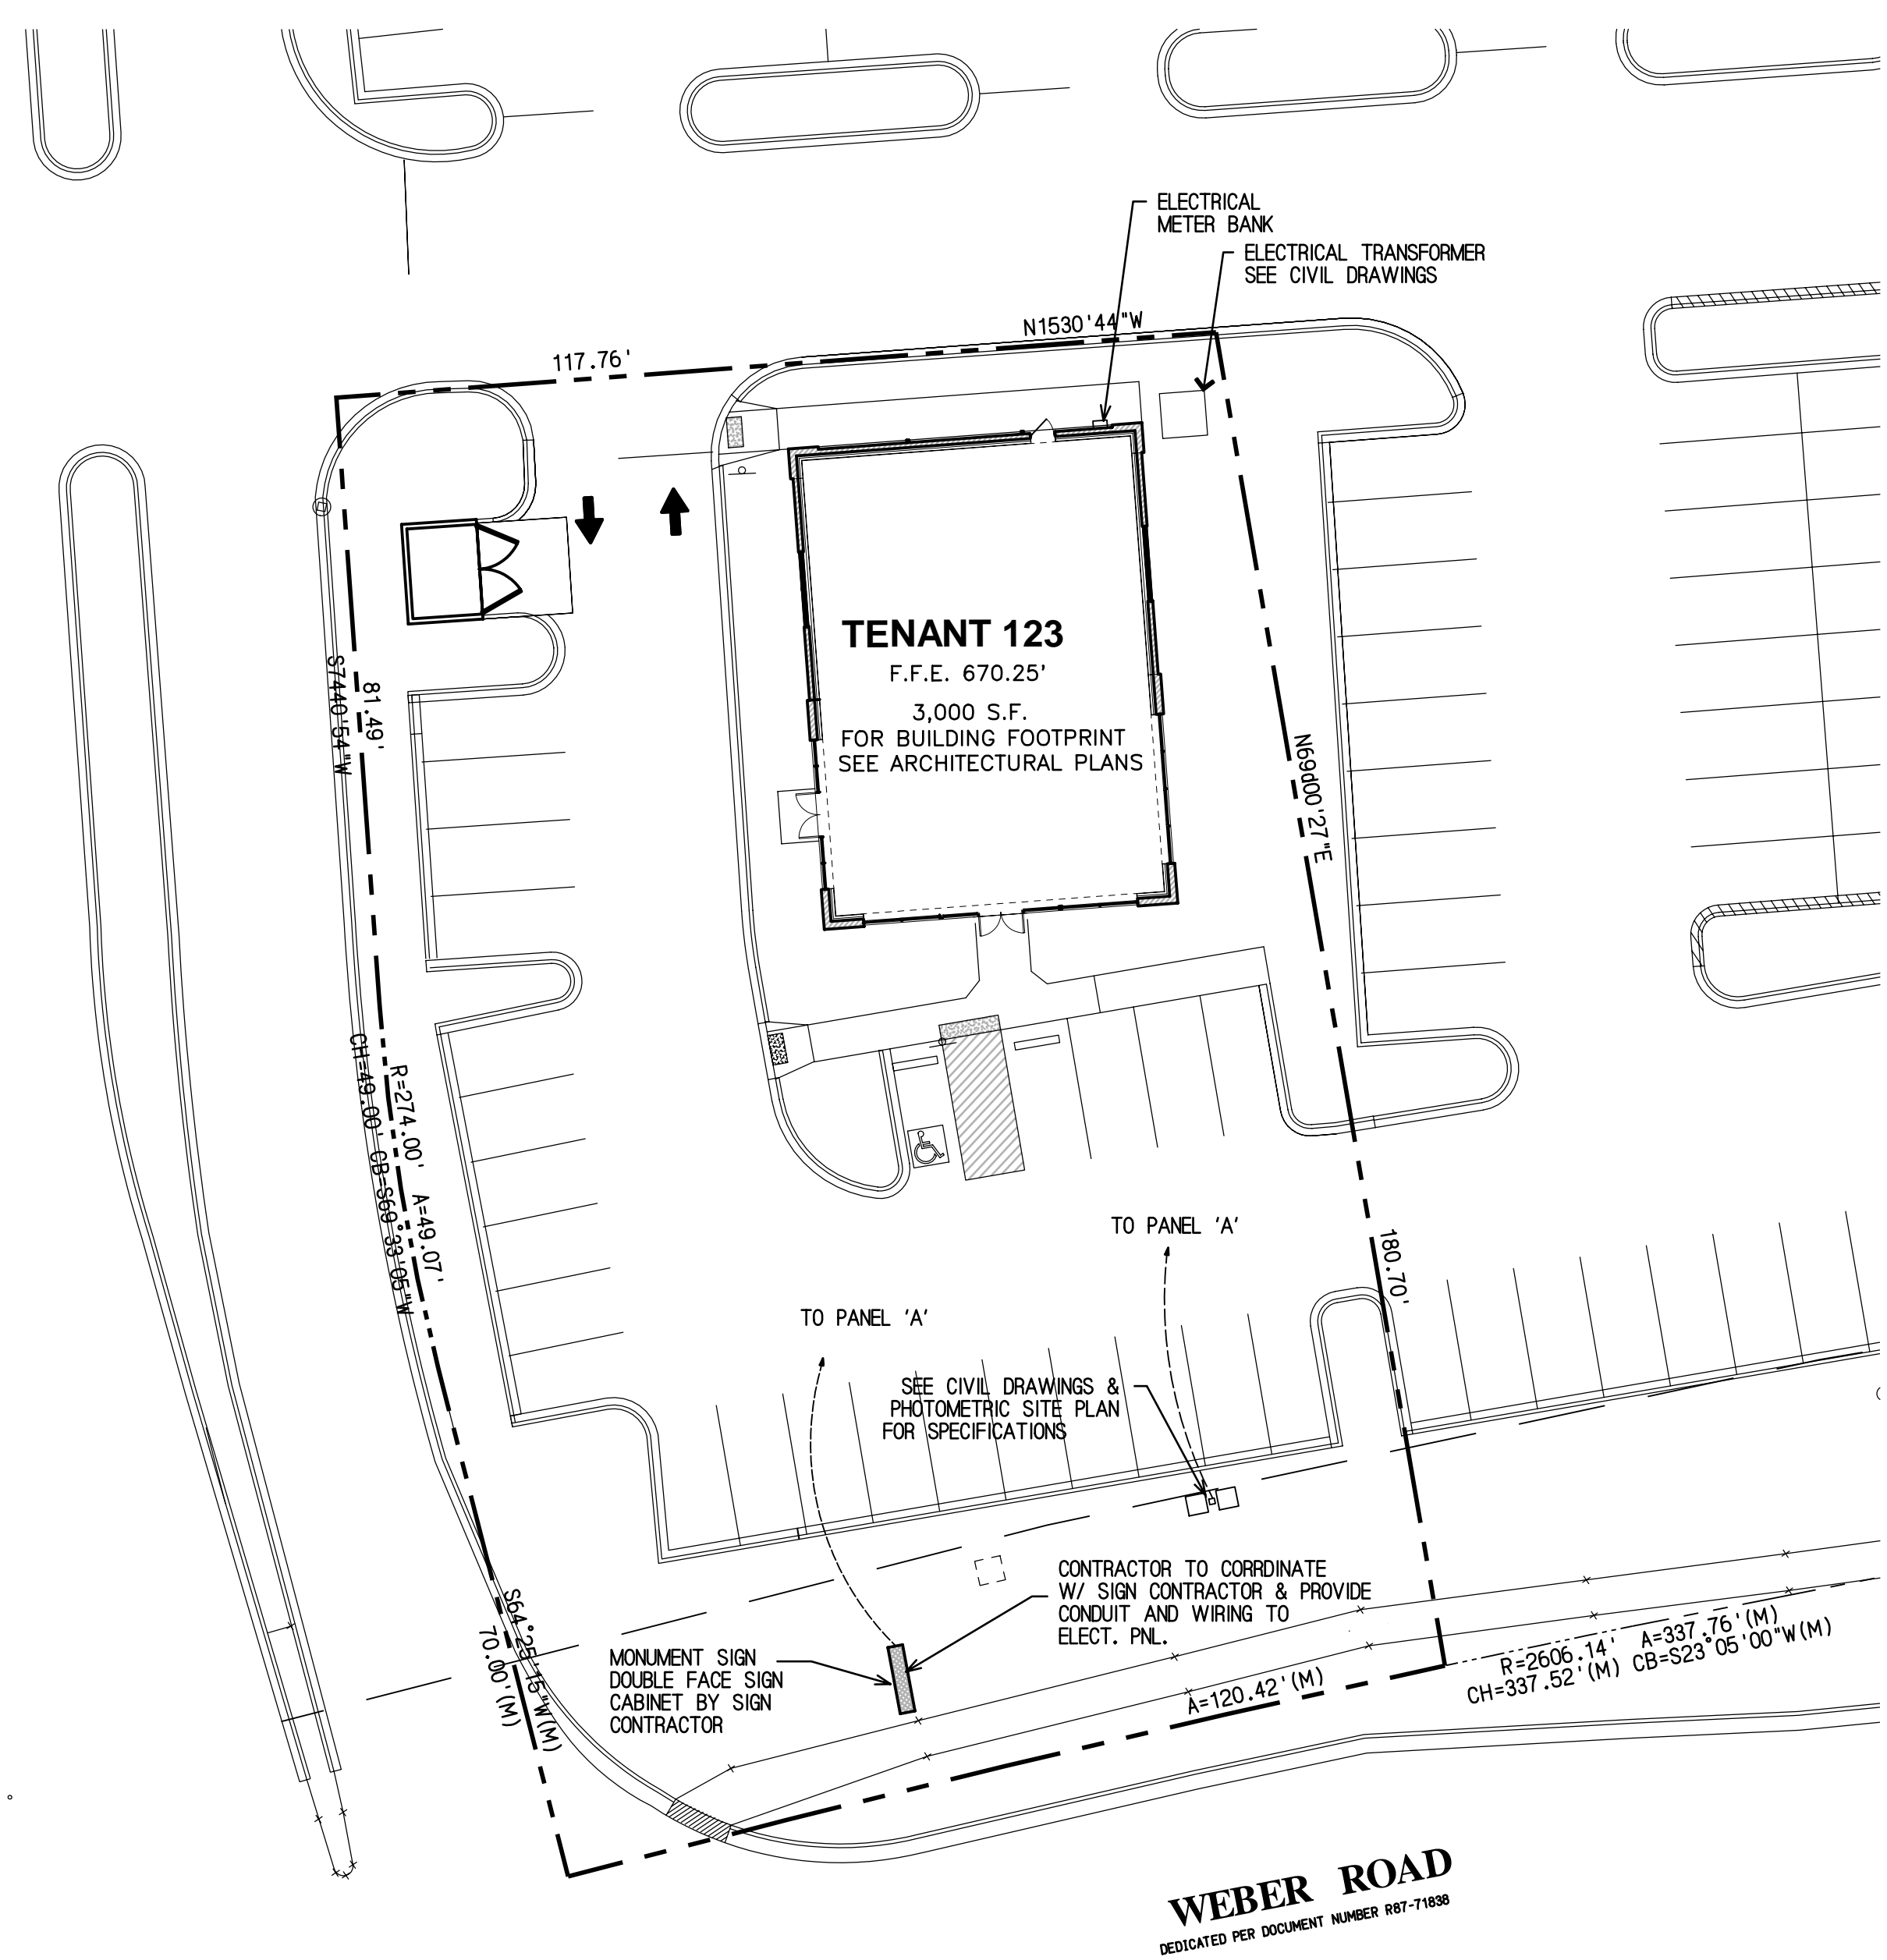

Site Electrical Plan
SCALE: 1"=20'-0"

